

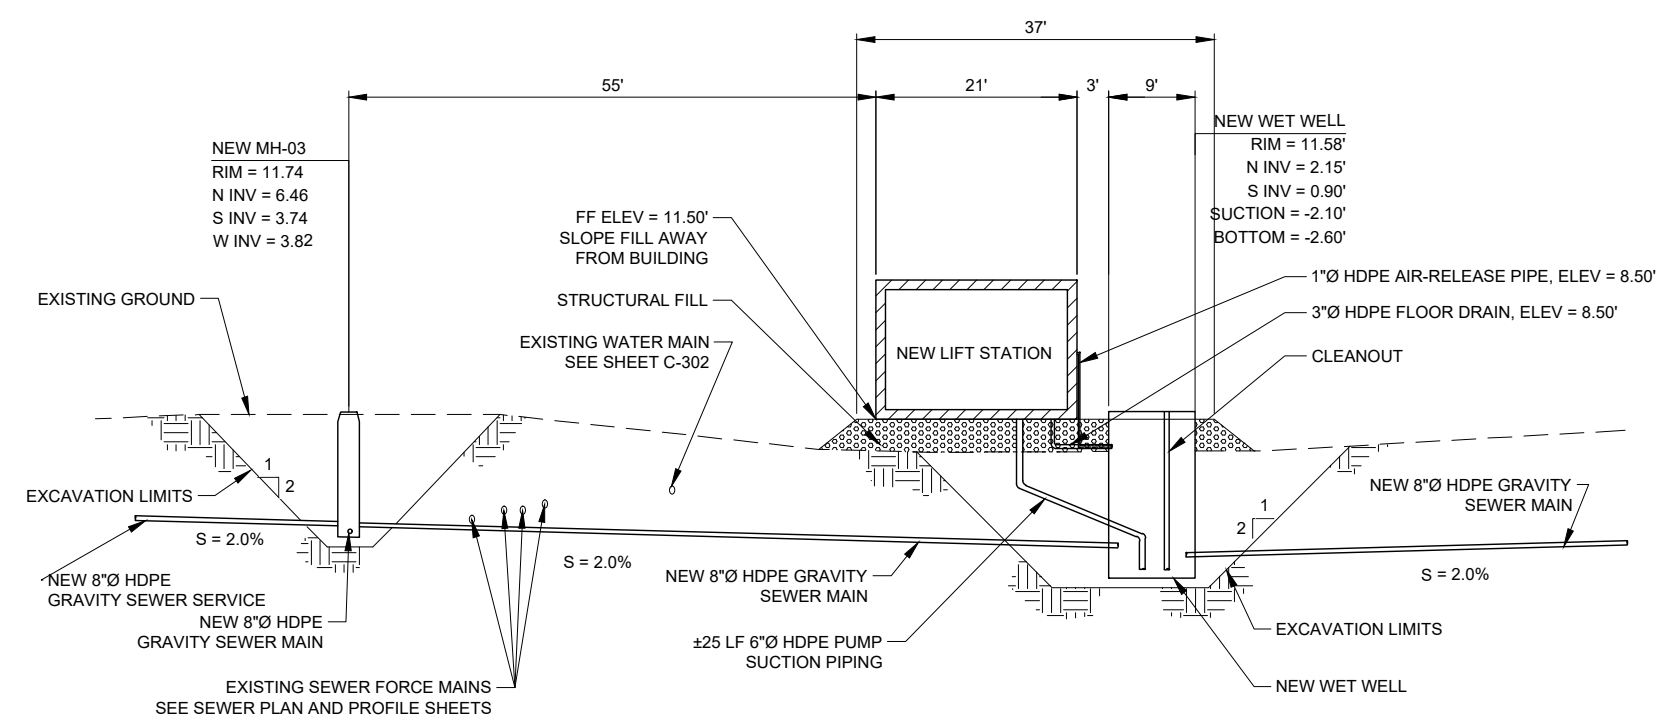


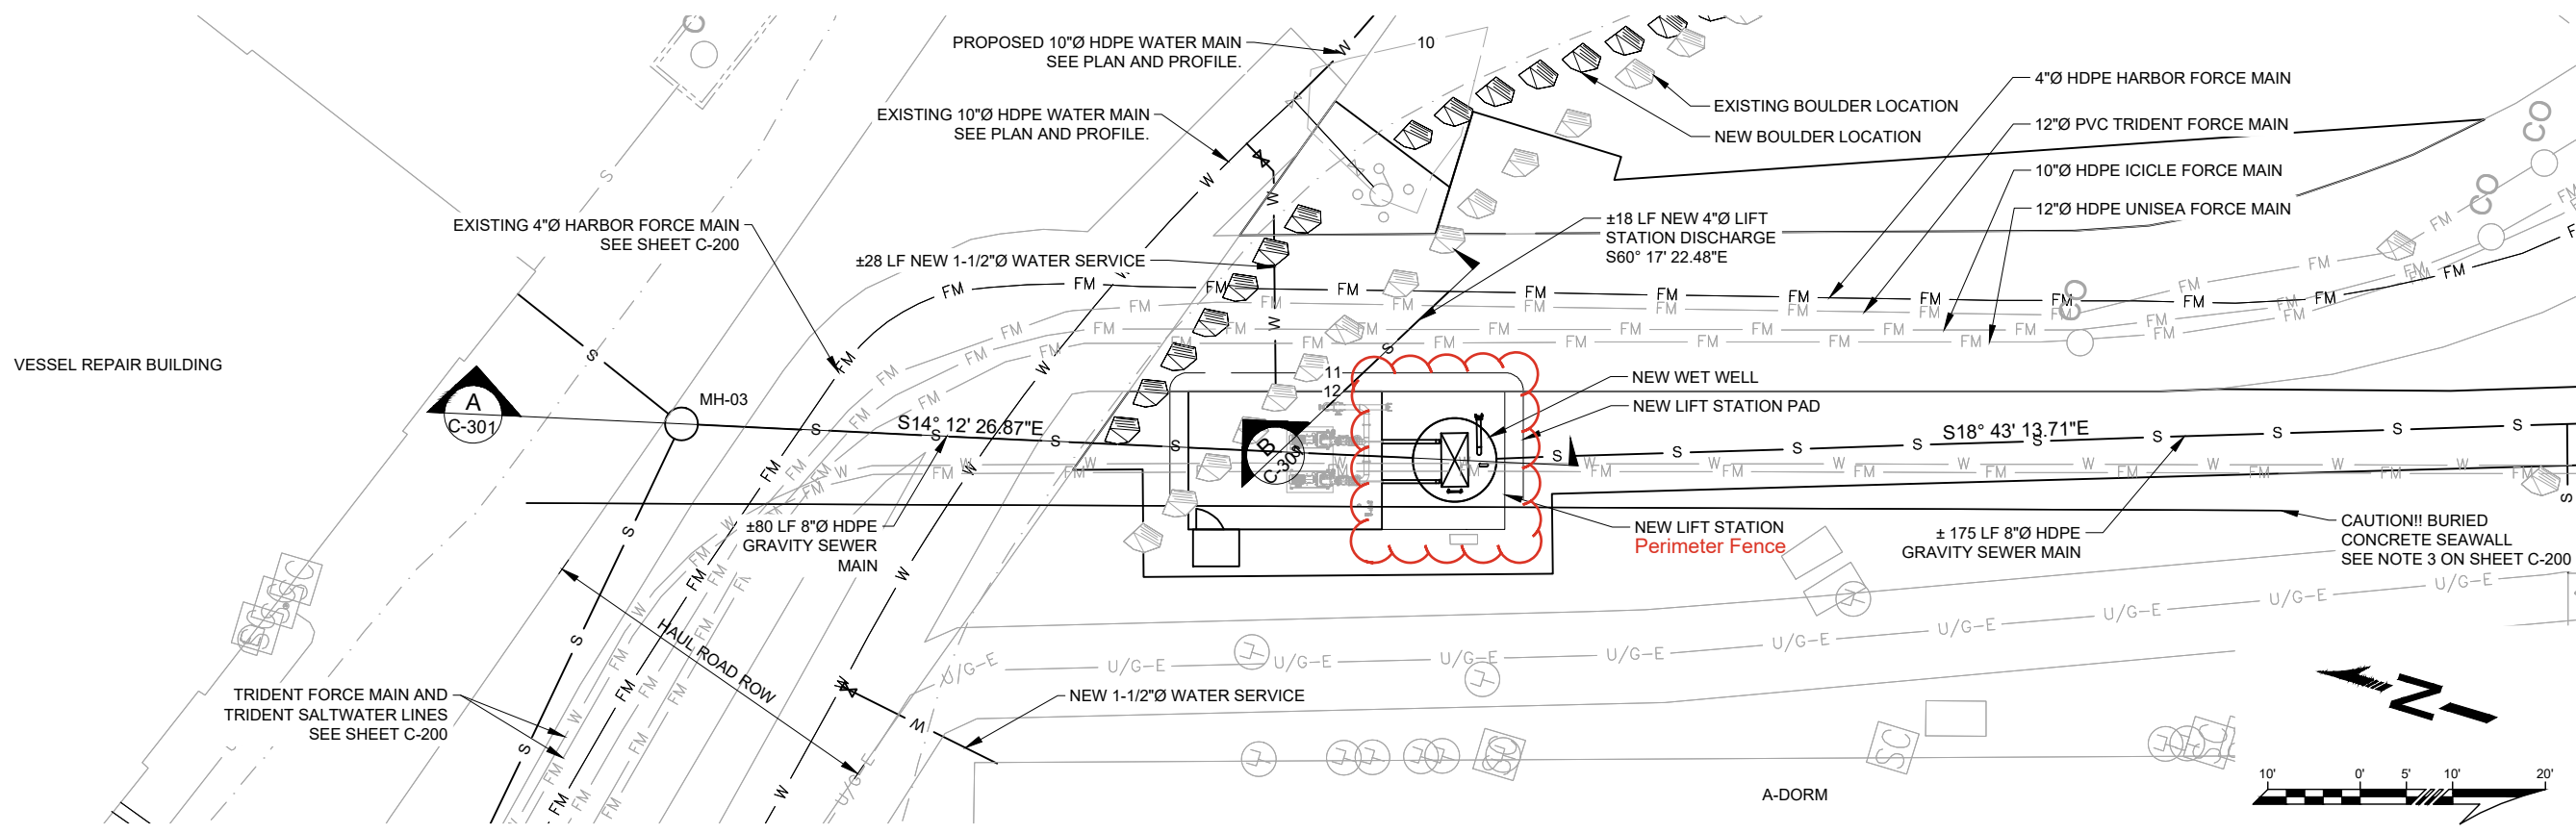

A SECTION A
SCALE: 1" = 10'

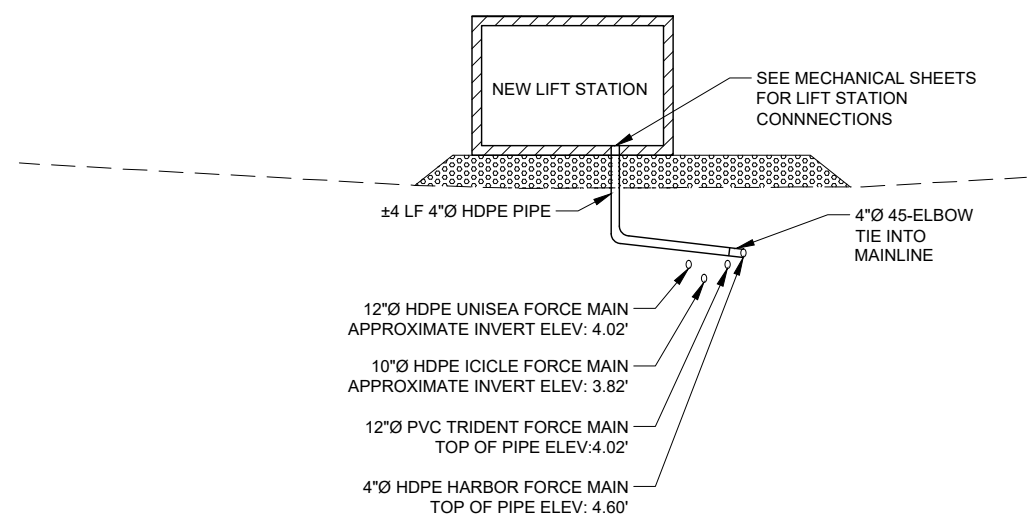

B SECTION B
SCALE: 1" = 10'

100% SUBMITTAL

KUNA
ENGINEERING
4300 B Street, Suite 605
Anchorage, AK 99503
Office: 907-339-6500
Fax: 907-339-6527
www.kuna-engineering.com
License Number: AEL12381

STATE OF ALASKA
49 TH
Daniel E. Nichols
No. CE 11012
REGISTERED PROFESSIONAL ENGINEER

REVISIONS & ADDENDUMS	
#	DATE

MANAGEMENT	
DESIGNED	BJK
DRAWN	BJK
CHECKED	BJD
APPROVED	DEN
LAST EDIT	2/22/24
PLOT DATE	2/22/24
SUBMITTAL	02/23/24

SMALL BOAT HARBOR UTILITIES
CITY OF SAINT PAUL
LIFT STATION PLAN AND PROFILE

PROJECT NUMBER: 165.030630
DRAWING FILE NAME: 030630-C-301-LIFT STATION P&P.DWG
DRAFTING SCALE: AS SHOWN

SHEET NUMBER
C-301